


PetroChina 217.9sqm

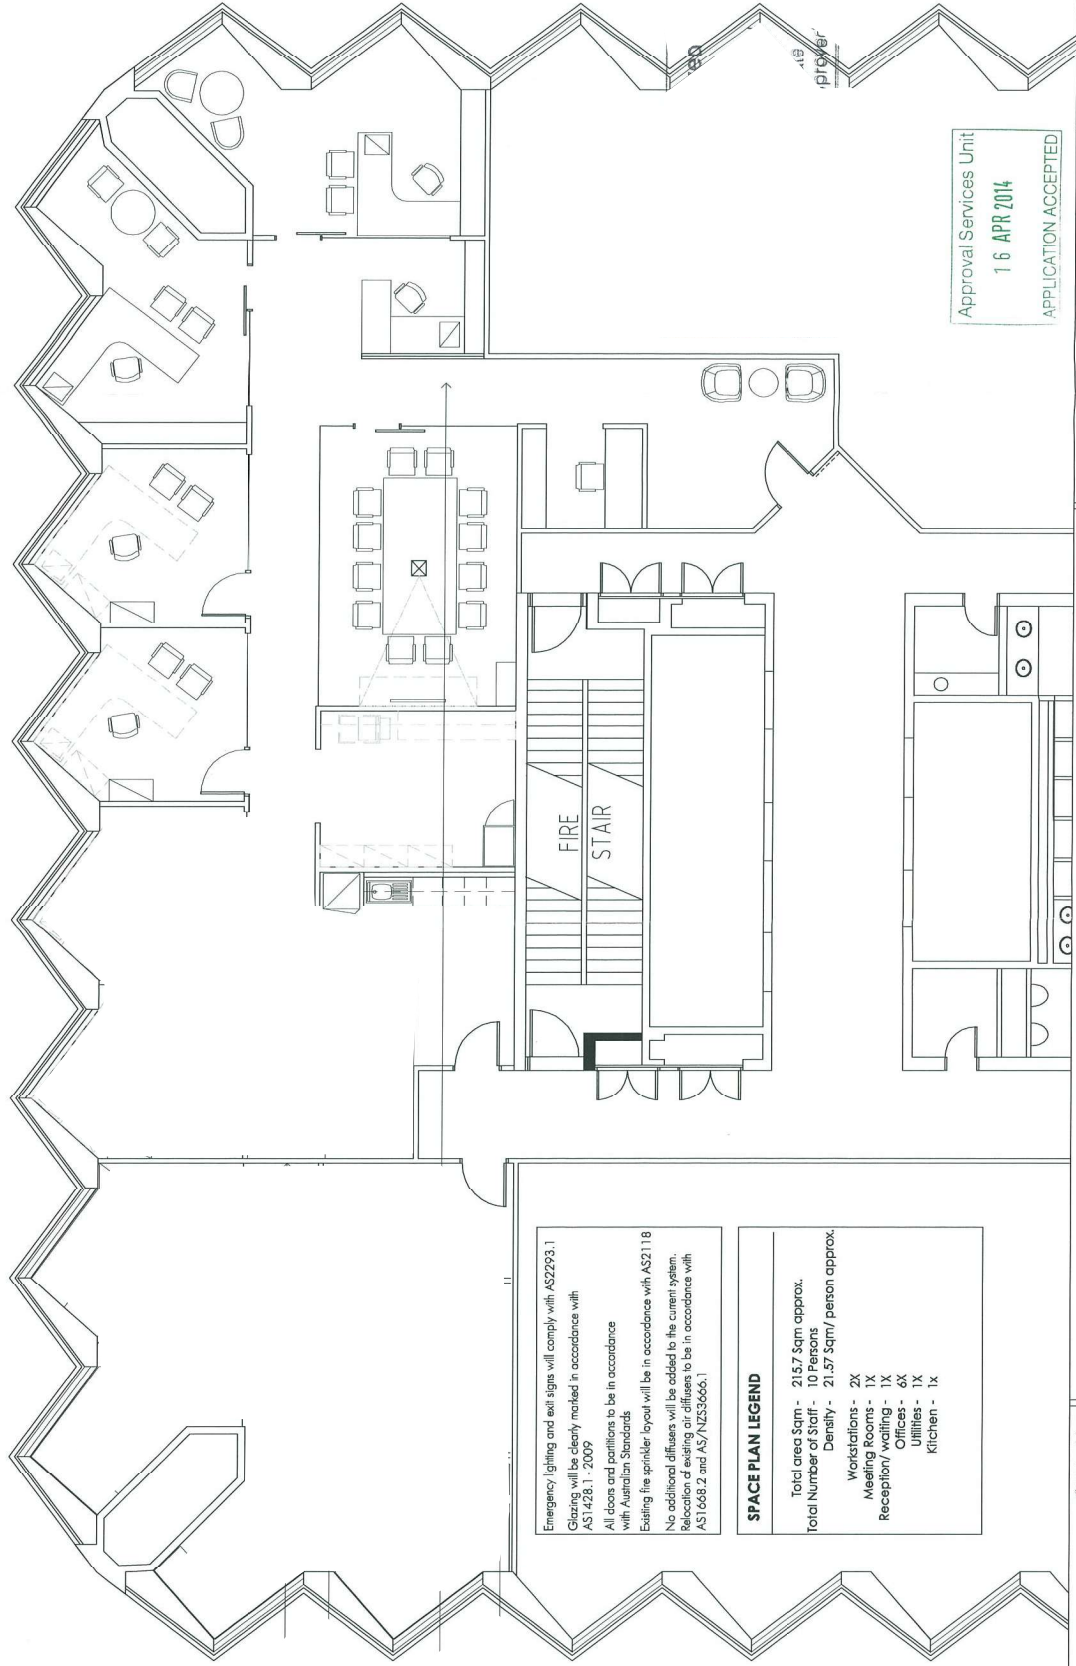

Emergency lighting and exit signs will comply with AS2293.1
Glazing will be clearly marked in accordance with
AS1428.1 - 2009
All doors and partitions to be in accordance
with Australian Standards
Existing fire sprinkler layout will be in accordance with AS2118
No additional diffusers will be added to the current system.
Relocation of existing air diffusers to be in accordance with
AS1668.2 and AS/NZS3666.1

SPACE PLAN LEGEND

Total area Sqm - 215.7 Sqm approx.
Total Number of Staff - 10 Persons
Density - 21.57 Sqm/ person approx.
Workstations - 2X
Meeting Rooms - 1X
Reception/ waiting - 1X
Offices - 6X
Utilities - 1X
Kitchen - 1X

Approval Services Unit
16 APR 2014
APPLICATION ACCEPTED

This drawing and design is subject to copyright and may, without written permission, not be reproduced or used in any form for any purpose other than that for which it was prepared. The client acknowledges that the design is preliminary and subject to change without notice. The client also acknowledges that the design is preliminary and subject to change without notice. The client also acknowledges that the design is preliminary and subject to change without notice.

client + address
PETROCHINA
120, 77 SCI
1004.14
quote no. QU_W12246
1 : 100 - (AS street)

L20_G
dwg no. SK01_preliminary

DESIGNED BY: LE

valmont

designer:
valmont
120, 77 SCI
Perth WA 6000
p. 08 9463 1012
w. www.valmont.com.au